




K:\Dwgs in Progress (Design)\899-004 Lee County Elevations\899-004 Lee County Elevations 11-20-2024 SK1.dwg, 12/3/2024 4:03:00

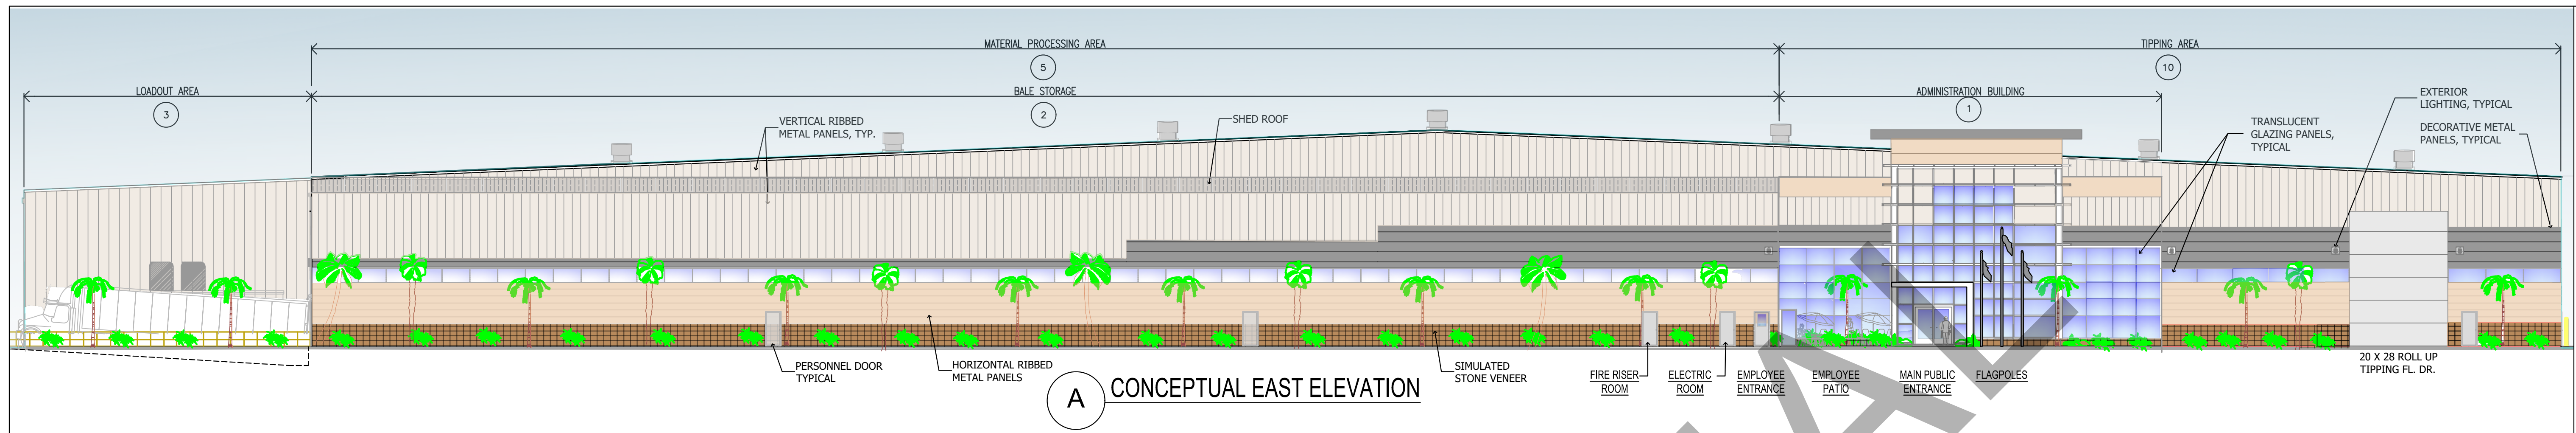


A CONCEPTUAL EAST ELEVATION

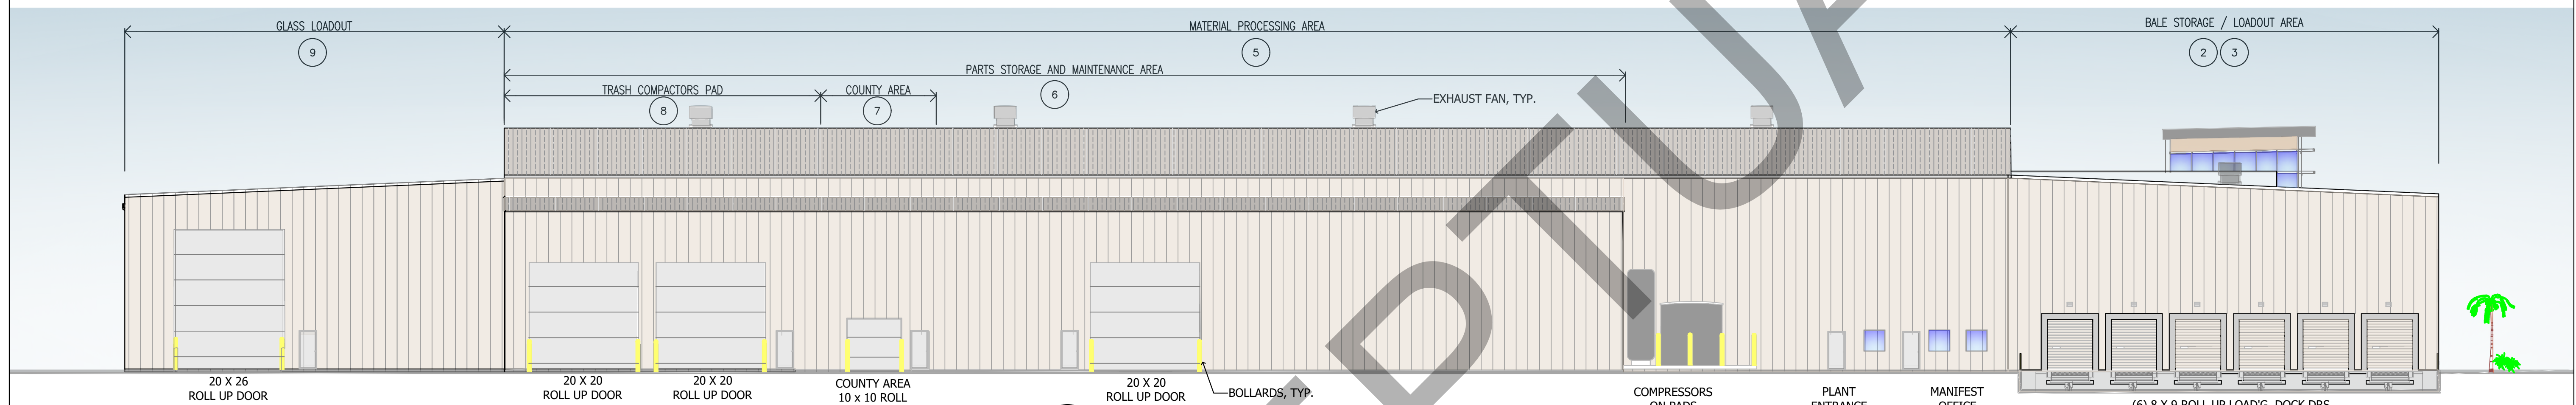

B CONCEPTUAL SOUTH ELEVATION

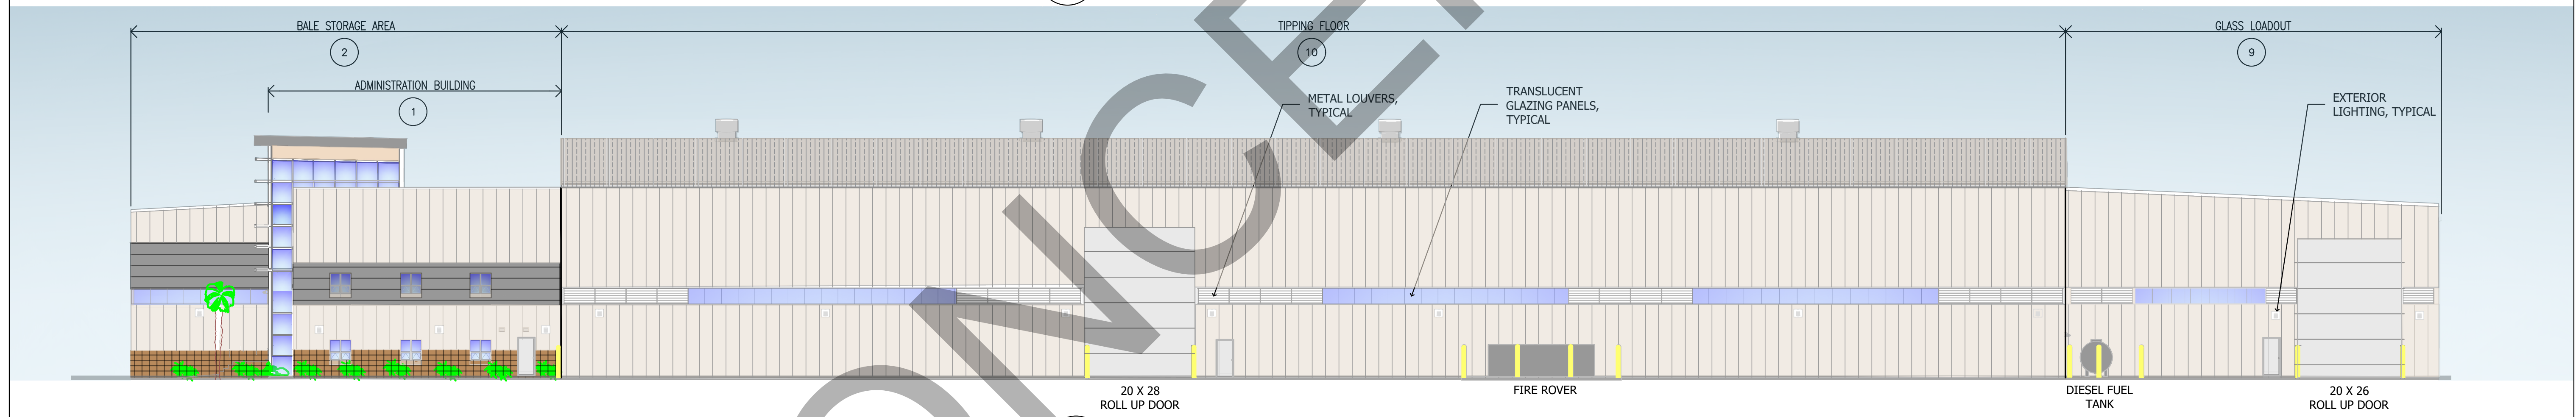

C CONCEPTUAL NORTH ELEVATION

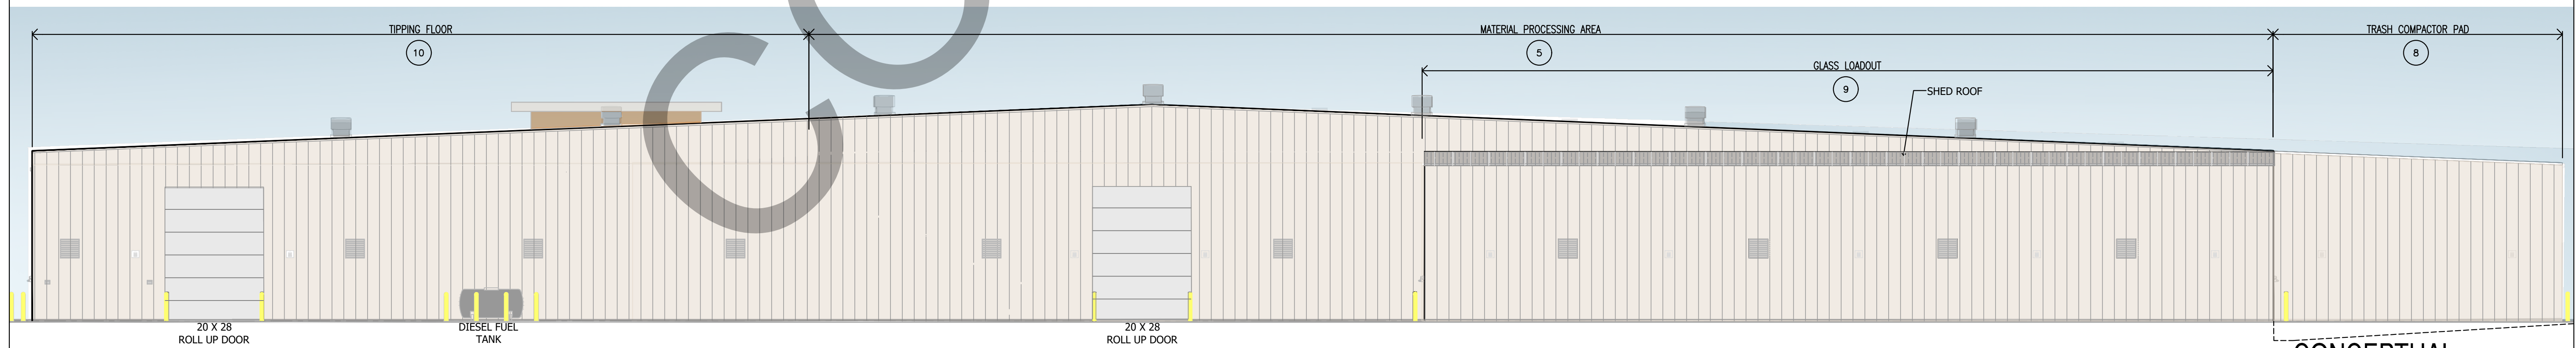

D CONCEPTUAL WEST ELEVATION

CONCEPTUAL
NOT FOR CONSTRUCTION
12/02/2024

JOHNSON ENGINEERING
 JOHNSON ENGINEERING, INC.
 2122 JOHNSON STREET
 P.O. BOX 1550
 FORT MYERS, FLORIDA 33902-1550
 PHONE: (239) 334-0046
 E.B. #642 & L.B. #642



RRT DESIGN & CONSTRUCTION
 A SERVICE OF ENVIRO-SERVICES &
 CONSTRUCTORS, INC.
 3 HUNTINGTON QUADRANGLE,
 SUITE 204S MELVILLE, NY 11747



**MATERIALS RECOVERY
PROCESSING FACILITY
LEE COUNTY, FLORIDA**

NO.	DATE	DESCRIPTION

DATE: 12-02-2024
 PROJECT NO. 899-004
 FILE NO. -
 SCALE: NONE

**CONCEPTUAL
COLOR
SCHEME
ELEVATIONS**

SHEET NUMBER
SK-3